

FOLLETT- QC DRAFTER SCOPE OF WORK

REVISION LOG:

Version	Date:	Revision notes:
5.6 (Current)	10/18/2018	Minor revisions
5.5	10/01/2018	Format update, minor revisions
5.1-5.4	Skipped	Skipped to keep format changes consistent numbers

INTRODUCTION TO PROJECT:

Welcome to the Follett project with FSU!

Our goals for this project are to collect all the information needed for our client to design new stores. FSU will be acting as the client's eyes and ears on site. Please pay attention for items that look out of the ordinary or expensive to correct.

CRITICAL PROJECT INFORMATION:			
Estimated QC time	8 hours		
FSU project contacts			
Project Manager:	Nik Turino	CAD Scheduling:	Jenna Miller
Project manager phone:	303-355-7274	CAD Scheduling phone:	303-355-7274
Project manager email:	nturino@fsusurveyor.com	CAD Scheduling email:	jmiller@fsusurveyor.com
FSU project Escalation:	For QC issues		
1. Project Manager:	Nik Turino		

CAD DRAFTER SCOPE OF WORK:	
CAD Template	FLT_XXXXX_CityST vX.X
Template type	Client template and layering
CAD Version	2010
CAD sheet size	24 x 36
CAD Floorplan Orientation	Main entry facing right or bottom depending on space layout
Delivery to FSU	Quickbase vendor portal
CAD Deliverables	A0.0 Title Sheet A1.0 Blockout plan (client name for floorplan) A1.1 Reflected Ceiling Plan A1A.0 Photo Survey (photo key plan) A2.0 Existing elevations A2.1 Existing elevations overflow
CAD Blocks	CAD drafter must use only the provided blocks and symbols that are included in the template
Layers	See below for layers and descriptions

Layers:	
Name	Description
0	Used to create blocks, DO NOT place anything on this layer
A-Anno-Rmnm	Room names
A-Anno-Tags	Room number and areas
A-Area	P-Line used for Follett department areas
A-Blockout-Note	Existing condition notes for the blockout plan
A-Ceiling	Existing ceiling condition notes
A-Clng-Grid	Existing ceiling grid
A-Clng-Ovhd	Overhead elements (bulkheads, beams, etc)
A-Clng-Soffit	Soffit locations
A-Clng-Symb	Ceiling and light symbols
A-Clng-Text	Ceiling notes and specifications
A-Cols	Structural column locations
A-Cols-Bubble	Column grid notations
A-Cols-Grid	Column grid
A-Construction-Notes	Construction notes
A-Dims	Architectural plan dimensions
A-Door	Existing doors
A-Door-Header	Door header
A-Elev-Note	Existing interior elevation notes
A-Elev-Symbol	Interior elevation symbols
A-Floor-Exist	Existing floor conditions
A-Fixt-Exist	All existing fixtures, furniture, gondolas, checkouts, register stations, all built in cabs or desks and associated text
A-Floor-Transition	Location of floor transitions
A-Floor-Vert	Vertical floor changes, stairs, and stair break lines
A-Gen-Notes	General Notes
A-Glaz-Exist	Windows
A-Glaz-Mull-Exist	Window mullions
A-Glaz-Sill-Exist	Window sills
A-Lease-Line	Existing lease line
A-Photo-Tag	Photo bubbles
A-Sect-Iden	Section symbol
A-Titlsht-Notes	Titlesheet notes
A-Wall-Exisit	Existing walls to be here
Defpoints	Definition points
E-Lite-Emer	Emergency light locations
E-Lite-Exist	Existing light locations
E-Lite-Note	Lighting locations notes

E-Power-Exist	Existing power locations and data locations, wall sconce and wall lights, and any other wall mounted electrical wall item.
E-Power-Exist-Note	All notes for items listed on “E-Power-Exist”
E-Power-Note	Electrical power location notations
E-Sert-Eqpm	Security equipment
F-Prot-Exist	Fire protections (sprinklers, etc)
G-Anno-Titlsht	Title sheet notations
G-Titlsht	Title sheet
G-Titlesht-Line1	Title sheet
G-Titlesht-Line2	Title sheet
Life Safety	Life safety (fire strobes, fire pulls, extinguishers, etc)
M-Mech-Exist	Existing HVAC locations
M-Mech-Note	HVAC notations
M-Mech-Symbol	HVAC symbol
P	Non plumbing fixture plumbing items, stalls, stall doors, grab bars
P-Eqpm	Plumbing fixtures (sinks, toilets, urinals)
T-Wifi	Wifi routers and extenders
Viewport	Used for paper space viewports


QC PROCESS	
CAD Template	<ul style="list-style-type: none"> o Confirm all title block information is correct o Confirm the total SF in the title block with P-line in model space o Verify site address and site ID # with Quickbase o Verify site address with Google Maps o Verify North Arrow with Google Maps o Add name in QC space in title block o Confirm Follett project name are filled out o Perform Layer walk to confirm all objects and lines are on the correct layers o Review each sheet (sheet break downs are below) o Delete all notes to drafter and hatch area o Set up elevations sheets o Wrap it up <ul style="list-style-type: none"> o Do ‘zoom extents’ in model space as well as each layout o Save the CAD file with ‘FINAL’ at the end o Plot all sheets to PDF and combine into 1 document. <ul style="list-style-type: none"> ▪ FLT_XXXXX_CityST(School name)-Final o Combine all still photos into one folder and zip together o Place Final CAD, PDFs, and Photos into the site folder on the project drive o Write “Ready for Upload” on hard copy and give to Nik o Quickbase: <ul style="list-style-type: none"> ▪ QC status – check the box “ready for delivery” ▪ Add time to QB time card ▪ Add drafting / survey feedback

SHEET A1.0 TITLE SHEET

<table border="1"> <tr><td>TITLE</td><td>NAME</td><td>EMAIL</td><td>XXX-XXX-XXXX</td></tr> <tr><td>TITLE</td><td>NAME</td><td>EMAIL</td><td>XXX-XXX-XXXX</td></tr> <tr><td>TITLE</td><td>NAME</td><td>EMAIL</td><td>XXX-XXX-XXXX</td></tr> </table>				TITLE	NAME	EMAIL	XXX-XXX-XXXX	TITLE	NAME	EMAIL	XXX-XXX-XXXX	TITLE	NAME	EMAIL	XXX-XXX-XXXX	PROJECT CONTACTS																																																																				
TITLE	NAME	EMAIL	XXX-XXX-XXXX																																																																																	
TITLE	NAME	EMAIL	XXX-XXX-XXXX																																																																																	
TITLE	NAME	EMAIL	XXX-XXX-XXXX																																																																																	
<table border="1"> <tr><td>LELLET STORE OPERATIONS</td><td></td><td></td><td></td></tr> <tr><td>STORE MANAGER</td><td>TBD</td><td>TBD@FOLLETT.COM</td><td>000-000-0000</td></tr> <tr><td>REGIONAL MANAGER</td><td>TBD</td><td>TBD@FOLLETT.COM</td><td>000-000-0000</td></tr> <tr><td>TITLE</td><td>NAME</td><td>EMAIL</td><td>XXX-XXX-XXXX</td></tr> </table>				LELLET STORE OPERATIONS				STORE MANAGER	TBD	TBD@FOLLETT.COM	000-000-0000	REGIONAL MANAGER	TBD	TBD@FOLLETT.COM	000-000-0000	TITLE	NAME	EMAIL	XXX-XXX-XXXX	SITE NUMBER AND NAME																																																																
LELLET STORE OPERATIONS																																																																																				
STORE MANAGER	TBD	TBD@FOLLETT.COM	000-000-0000																																																																																	
REGIONAL MANAGER	TBD	TBD@FOLLETT.COM	000-000-0000																																																																																	
TITLE	NAME	EMAIL	XXX-XXX-XXXX																																																																																	
<table border="1"> <tr><td>LELLET STORE DESIGN</td><td></td><td></td><td></td></tr> <tr><td>PROJECT MANAGER</td><td>TBD</td><td>TBD@FOLLETT.COM</td><td>000-000-0000</td></tr> <tr><td>DESIGNER</td><td>TBD</td><td>TBD@FOLLETT.COM</td><td>000-000-0000</td></tr> <tr><td>GENERAL CONTRACTOR</td><td>TBD</td><td>TBD@SMAL.COM</td><td>000-000-0000</td></tr> <tr><td>OWNER</td><td></td><td></td><td></td></tr> <tr><td>CLIENT</td><td>ROBBY RUSSELL</td><td>ROBBY.RUSSELL@FOCUS-IND.COM</td><td>903-669-8534</td></tr> <tr><td>CLIENT</td><td>DARRIN HAMNER</td><td>DARRIN.HAMNER@FOCUS-IND.COM</td><td>903-669-2197</td></tr> <tr><td>DESIGNER</td><td></td><td></td><td></td></tr> <tr><td>PROPERTY STORE</td><td>JULIA SCHAK</td><td>JULIA@SPECIALTYSTORESERVICES.COM</td><td>847-954-5223</td></tr> <tr><td>FLOORING MATERIALS</td><td></td><td></td><td></td></tr> <tr><td>PAVING</td><td>SARAH PICKETT</td><td>SARAH.PICKETT@SIRAWINC.COM</td><td>706-532-7481</td></tr> <tr><td>WALL CABLING</td><td></td><td></td><td></td></tr> <tr><td>EDUC</td><td>CINDY MIRABILE</td><td>CMIRABILE@MSDUNINC.COM</td><td>630-734-7330</td></tr> <tr><td>ISAC</td><td></td><td></td><td></td></tr> <tr><td>WOOD</td><td>JOSHUA SCHAFER</td><td>JOSHUA.SCHAFFER@MOGOMEDIA.COM</td><td>512-563-9304</td></tr> <tr><td>PLUMB FURNITURE</td><td></td><td></td><td></td></tr> <tr><td>PLUMB COUNTY</td><td>CHUCK PERKEL</td><td>CHUCK@TCOF.COM</td><td>805-658-6600</td></tr> <tr><td>PLUMB COMPANY NAME</td><td>CONTACT</td><td>EMAIL</td><td>XXX-XXX-XXXX</td></tr> </table>				LELLET STORE DESIGN				PROJECT MANAGER	TBD	TBD@FOLLETT.COM	000-000-0000	DESIGNER	TBD	TBD@FOLLETT.COM	000-000-0000	GENERAL CONTRACTOR	TBD	TBD@SMAL.COM	000-000-0000	OWNER				CLIENT	ROBBY RUSSELL	ROBBY.RUSSELL@FOCUS-IND.COM	903-669-8534	CLIENT	DARRIN HAMNER	DARRIN.HAMNER@FOCUS-IND.COM	903-669-2197	DESIGNER				PROPERTY STORE	JULIA SCHAK	JULIA@SPECIALTYSTORESERVICES.COM	847-954-5223	FLOORING MATERIALS				PAVING	SARAH PICKETT	SARAH.PICKETT@SIRAWINC.COM	706-532-7481	WALL CABLING				EDUC	CINDY MIRABILE	CMIRABILE@MSDUNINC.COM	630-734-7330	ISAC				WOOD	JOSHUA SCHAFER	JOSHUA.SCHAFFER@MOGOMEDIA.COM	512-563-9304	PLUMB FURNITURE				PLUMB COUNTY	CHUCK PERKEL	CHUCK@TCOF.COM	805-658-6600	PLUMB COMPANY NAME	CONTACT	EMAIL	XXX-XXX-XXXX	SITE ADDRESS								
LELLET STORE DESIGN																																																																																				
PROJECT MANAGER	TBD	TBD@FOLLETT.COM	000-000-0000																																																																																	
DESIGNER	TBD	TBD@FOLLETT.COM	000-000-0000																																																																																	
GENERAL CONTRACTOR	TBD	TBD@SMAL.COM	000-000-0000																																																																																	
OWNER																																																																																				
CLIENT	ROBBY RUSSELL	ROBBY.RUSSELL@FOCUS-IND.COM	903-669-8534																																																																																	
CLIENT	DARRIN HAMNER	DARRIN.HAMNER@FOCUS-IND.COM	903-669-2197																																																																																	
DESIGNER																																																																																				
PROPERTY STORE	JULIA SCHAK	JULIA@SPECIALTYSTORESERVICES.COM	847-954-5223																																																																																	
FLOORING MATERIALS																																																																																				
PAVING	SARAH PICKETT	SARAH.PICKETT@SIRAWINC.COM	706-532-7481																																																																																	
WALL CABLING																																																																																				
EDUC	CINDY MIRABILE	CMIRABILE@MSDUNINC.COM	630-734-7330																																																																																	
ISAC																																																																																				
WOOD	JOSHUA SCHAFER	JOSHUA.SCHAFFER@MOGOMEDIA.COM	512-563-9304																																																																																	
PLUMB FURNITURE																																																																																				
PLUMB COUNTY	CHUCK PERKEL	CHUCK@TCOF.COM	805-658-6600																																																																																	
PLUMB COMPANY NAME	CONTACT	EMAIL	XXX-XXX-XXXX																																																																																	
<table border="1"> <tr><td>SCOPE OF WORK</td><td></td><td></td><td></td></tr> <tr><td colspan="4">BY FOLLETT GC</td></tr> <tr><td>FLOORING</td><td></td><td></td><td></td></tr> <tr><td>WALLS</td><td></td><td></td><td></td></tr> <tr><td>CEILING</td><td></td><td></td><td></td></tr> <tr><td>DISPLAY FIXTURES</td><td></td><td></td><td></td></tr> <tr><td>NETWORK</td><td></td><td></td><td></td></tr> <tr><td>ELECTRICAL</td><td></td><td></td><td></td></tr> <tr><td>GENERAL LIGHTING</td><td></td><td></td><td></td></tr> <tr><td>ACCENT LIGHTING</td><td></td><td></td><td></td></tr> <tr><td>CONSTRUCTION</td><td></td><td></td><td></td></tr> <tr><td>STOCKROOM</td><td></td><td></td><td></td></tr> <tr><td>OFFICE</td><td></td><td></td><td></td></tr> <tr><td>STOREFRONT</td><td></td><td></td><td></td></tr> <tr><td>PLUMBING</td><td></td><td></td><td></td></tr> <tr><td>OTHER</td><td></td><td></td><td></td></tr> <tr><td colspan="4">BY FOLLETT VENDORS</td></tr> <tr><td>DATA CABLING</td><td></td><td></td><td></td></tr> <tr><td>SECURITY</td><td></td><td></td><td></td></tr> </table>				SCOPE OF WORK				BY FOLLETT GC				FLOORING				WALLS				CEILING				DISPLAY FIXTURES				NETWORK				ELECTRICAL				GENERAL LIGHTING				ACCENT LIGHTING				CONSTRUCTION				STOCKROOM				OFFICE				STOREFRONT				PLUMBING				OTHER				BY FOLLETT VENDORS				DATA CABLING				SECURITY				SCOPE OF WORK				
SCOPE OF WORK																																																																																				
BY FOLLETT GC																																																																																				
FLOORING																																																																																				
WALLS																																																																																				
CEILING																																																																																				
DISPLAY FIXTURES																																																																																				
NETWORK																																																																																				
ELECTRICAL																																																																																				
GENERAL LIGHTING																																																																																				
ACCENT LIGHTING																																																																																				
CONSTRUCTION																																																																																				
STOCKROOM																																																																																				
OFFICE																																																																																				
STOREFRONT																																																																																				
PLUMBING																																																																																				
OTHER																																																																																				
BY FOLLETT VENDORS																																																																																				
DATA CABLING																																																																																				
SECURITY																																																																																				
<table border="1"> <tr><td colspan="4">DRAWING INDEX</td></tr> <tr><td>A0.0</td><td>TITLE SHEET</td><td>DATE</td><td></td></tr> <tr><td>A1.0</td><td>BLOCKOUT PLAN</td><td>DATE</td><td></td></tr> <tr><td>A1.1</td><td>BLOCKOUT PLAN</td><td>DATE</td><td></td></tr> <tr><td>A1.2</td><td>REFLECTED CEILING PLAN</td><td>DATE</td><td></td></tr> <tr><td>A1.A.0</td><td>PHOTO SURVEY</td><td>DATE</td><td></td></tr> <tr><td>A1.A.1</td><td>PHOTO SURVEY</td><td>DATE</td><td></td></tr> <tr><td>A2.0</td><td>EXISTING ELEVATIONS</td><td>DATE</td><td></td></tr> <tr><td>A3.0</td><td>DEMOLITION PLAN</td><td>DATE</td><td></td></tr> <tr><td>A4.0</td><td>NEW CONSTRUCTION PLAN</td><td>DATE</td><td></td></tr> <tr><td>A5.0</td><td>NEW CONSTRUCTION ELEVATIONS</td><td>DATE</td><td></td></tr> <tr><td>A6.0</td><td>ELECTRICAL AND DATA/ELE PLANS</td><td>DATE</td><td></td></tr> <tr><td>A6.1</td><td>COORD NOTES & LEGENDS</td><td>DATE</td><td></td></tr> <tr><td>A7.0</td><td>ACCENT LIGHTING PLAN</td><td>DATE</td><td></td></tr> <tr><td>A8.0</td><td>FIXTURE PLAN</td><td>DATE</td><td></td></tr> <tr><td>A9.0</td><td>DEMO FLOORING PLAN</td><td>DATE</td><td></td></tr> <tr><td>A9.1</td><td>NEW FLOORING PLAN</td><td>DATE</td><td></td></tr> <tr><td>A10.0</td><td>INTERIOR FINISH ELEVATION</td><td>DATE</td><td></td></tr> <tr><td>A11.0</td><td>NOT USPP</td><td>DATE</td><td></td></tr> <tr><td>A12.0</td><td>WALLS</td><td>DATE</td><td></td></tr> </table>				DRAWING INDEX				A0.0	TITLE SHEET	DATE		A1.0	BLOCKOUT PLAN	DATE		A1.1	BLOCKOUT PLAN	DATE		A1.2	REFLECTED CEILING PLAN	DATE		A1.A.0	PHOTO SURVEY	DATE		A1.A.1	PHOTO SURVEY	DATE		A2.0	EXISTING ELEVATIONS	DATE		A3.0	DEMOLITION PLAN	DATE		A4.0	NEW CONSTRUCTION PLAN	DATE		A5.0	NEW CONSTRUCTION ELEVATIONS	DATE		A6.0	ELECTRICAL AND DATA/ELE PLANS	DATE		A6.1	COORD NOTES & LEGENDS	DATE		A7.0	ACCENT LIGHTING PLAN	DATE		A8.0	FIXTURE PLAN	DATE		A9.0	DEMO FLOORING PLAN	DATE		A9.1	NEW FLOORING PLAN	DATE		A10.0	INTERIOR FINISH ELEVATION	DATE		A11.0	NOT USPP	DATE		A12.0	WALLS	DATE		DRAWING INDEX
DRAWING INDEX																																																																																				
A0.0	TITLE SHEET	DATE																																																																																		
A1.0	BLOCKOUT PLAN	DATE																																																																																		
A1.1	BLOCKOUT PLAN	DATE																																																																																		
A1.2	REFLECTED CEILING PLAN	DATE																																																																																		
A1.A.0	PHOTO SURVEY	DATE																																																																																		
A1.A.1	PHOTO SURVEY	DATE																																																																																		
A2.0	EXISTING ELEVATIONS	DATE																																																																																		
A3.0	DEMOLITION PLAN	DATE																																																																																		
A4.0	NEW CONSTRUCTION PLAN	DATE																																																																																		
A5.0	NEW CONSTRUCTION ELEVATIONS	DATE																																																																																		
A6.0	ELECTRICAL AND DATA/ELE PLANS	DATE																																																																																		
A6.1	COORD NOTES & LEGENDS	DATE																																																																																		
A7.0	ACCENT LIGHTING PLAN	DATE																																																																																		
A8.0	FIXTURE PLAN	DATE																																																																																		
A9.0	DEMO FLOORING PLAN	DATE																																																																																		
A9.1	NEW FLOORING PLAN	DATE																																																																																		
A10.0	INTERIOR FINISH ELEVATION	DATE																																																																																		
A11.0	NOT USPP	DATE																																																																																		
A12.0	WALLS	DATE																																																																																		
				SITE MAP																																																																																

Title Block	<ul style="list-style-type: none"> Fill in all title block information Update the total SF in the title block Sheet number: A0.0 Sheet name: Title Sheet
Site Map	<ul style="list-style-type: none"> Use a google maps screen shot. Make sure that the image is not x-refed but imbedded into the CAD file using special paste Show the entire school and the surrounding roads
Drawing index	<ul style="list-style-type: none"> Update this table every project to reflect sheets used on the site Confirm sheet A2.1 is used or not used
Project contacts	<ul style="list-style-type: none"> Update the site number and school name only
Scope of Work	<ul style="list-style-type: none"> Not in scope, Do not change anything in this area
Project Address	<ul style="list-style-type: none"> Fill in the Follett site number, site name, and address Fill in this information in 2 areas, the sheet and the title block

SHEET A1.0 BLOCKOUT PLAN

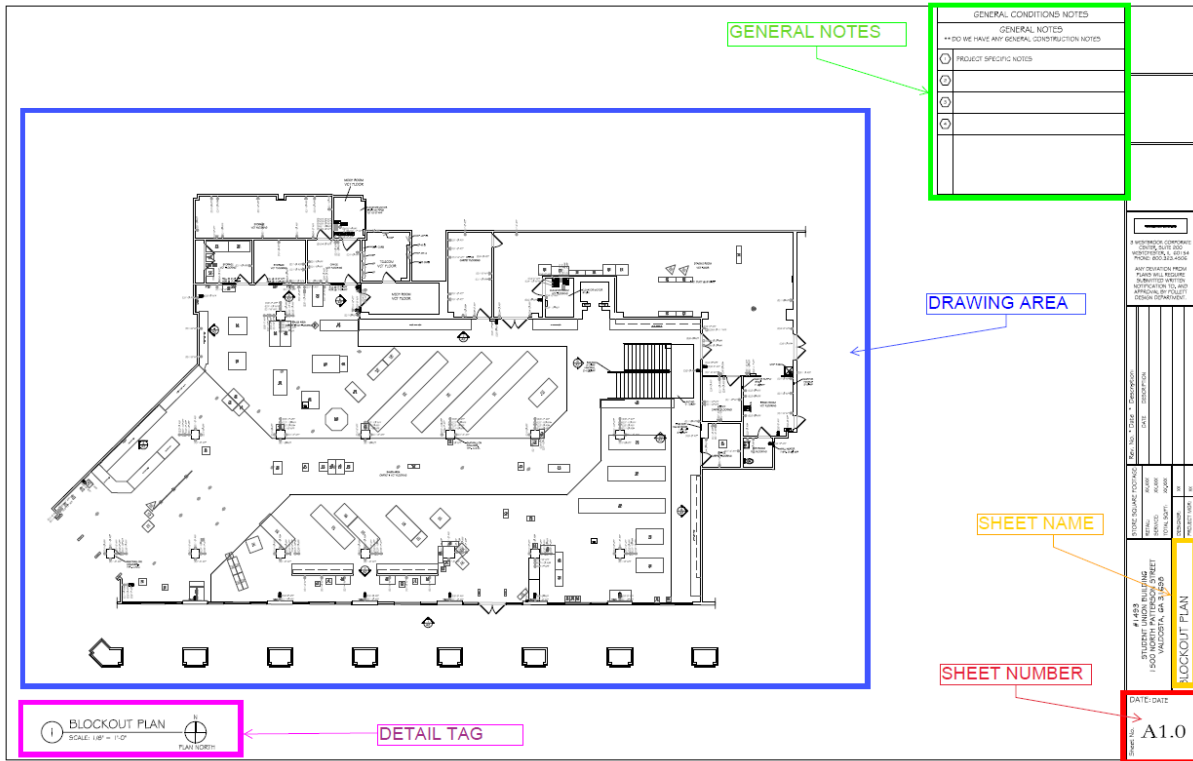


Title Block	<ul style="list-style-type: none"> ○ Fill in all title block information ○ Update the total SF in the title block ○ Sheet number: A1.0 ○ Sheet name: Blockout Plan
Detail Tag	<ul style="list-style-type: none"> ○ Listed scale will match the viewport scale ○ Adjust north arrow to correct position
Drawing area	<ul style="list-style-type: none"> ○ Viewport: 1/4"=1'-0" if possible, 1/8" = 1'-0" is the smallest. If the drawing will not fit on 1/8" = 1'-0" then a key plan and blowup areas are required at 1/4"=1'-0"
General notes	<ul style="list-style-type: none"> ○ Not in Scope, Do not change anything in this area
Floorplan	<ul style="list-style-type: none"> ○ All doors, walls, windows, half walls, built ins ○ Indicate demising wall thickness, ○ Indicate exterior wall thickness at front and rear of space, or all walls that are exposed to the exterior. ○ Window sill and header heights ○ Show all soffits and ceiling type/height changes ○ Note all floor and wall finishes ○ Elevation markers for exterior storefront and interior elevations ○ All section and elevation callouts must match their corresponding detail location
All MEP (to be shown on Floorplan)	<ul style="list-style-type: none"> ○ Mechanical: Exact placement of all mechanical elements including AFFs. <ul style="list-style-type: none"> ▪ Exact size (W x H x D, and AFF) and placement of Mechanical equipment including wall/floor mounted heaters ○ Electrical: Exact placement of all electrical elements including AFFs. <ul style="list-style-type: none"> ▪ Exact size (W x H x D, and AFF) and placement of all major electrical and telecom equipment located within the Follett space.


	<ul style="list-style-type: none"> ▪ Include all Electrical Panel Boxes, meters, transformers, disconnects, main distribution panels ▪ Telecom equipment including demark, tele/data boards, routers, 66 blocks, etc. if located within the store. ▪ Include all wall and floor electrical/data/telephone outlets ▪ Include all wall mounted lights/sconces, cameras, sensors, lighting control panels, alarm key pad, music controls, thermostats, fire extinguisher/hose cabinets fire alarm equipment, fire alarm pull stations, fire strobes/horns, emergency lighting and any other wall mounted items not listed. ○ Plumbing: Exact placement of all plumbing elements including AFFs. <ul style="list-style-type: none"> ▪ Exact placement of all plumbing elements within the surveyed space ▪ Restroom fixtures and stalls ▪ Grab bar size (length & AFF) and location ▪ Sinks, mop sinks, floor drains, and floor sinks ▪ Hot water heaters ▪ Clean-outs ▪ Exposed water lines and gas lines
--	---

SHEETA1.0-SHEET ELEMENTS: WALLS	
Layer	<ul style="list-style-type: none"> ○ A-Wall-Exisit <ul style="list-style-type: none"> ▪ Existing walls, half walls
General information	<ul style="list-style-type: none"> ○ All walls must be snapped closed ○ No overlapping lines ○ Walls must be drawn in a continues line, not segmented ○ All demising walls around the space must show a depth ○ Drawing orientation should be with the main entry pointing down or to the right



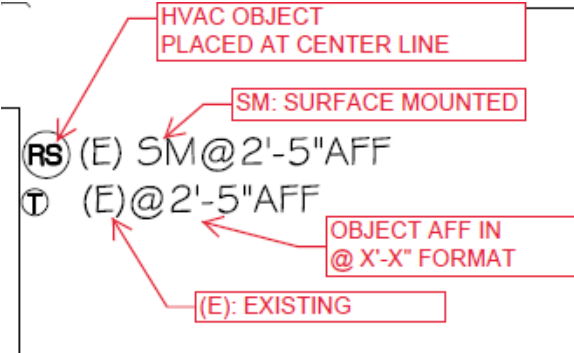
SHEETA1.0-SHEET ELEMENTS: DOORS	
Layer	<ul style="list-style-type: none"> ○ A-Door <ul style="list-style-type: none"> ▪ Existing doors and door jams ○ A-Door-Header <ul style="list-style-type: none"> ▪ Existing Door headers
General information	<ul style="list-style-type: none"> ○ Must use client proved door blocks ○ Existing doors must be shown at 45 degrees open ○ All walls must be cut for doors ○ All doors must have header if they exist on site ○ All doors must show correct swing

SHEETA1.0-SHEET ELEMENTS: WINDOWS	
Layer	<ul style="list-style-type: none"> ○ A-Glaz-Exist <ul style="list-style-type: none"> ▪ Existing window glazing ○ A-Glaz-Mull-Exist <ul style="list-style-type: none"> ▪ Existing window mullions ○ A-Glaz-Sill-Exist <ul style="list-style-type: none"> ▪ Existing window sill ○ A-Blockout-Note <ul style="list-style-type: none"> ▪ Existing window sill and head height callout
General information	<ul style="list-style-type: none"> ○ Must show mullions and glazing ○ Must call out window sill and head height


SHEETA1.0-SHEET ELEMENTS: ROOM CALLOUTS	
Layer	<ul style="list-style-type: none"> ○ A-Anno-Rmnm <ul style="list-style-type: none"> ▪ Room name ○ A-Floor-Exist <ul style="list-style-type: none"> ▪ Existing flooring ○ A-Blockout-Note <ul style="list-style-type: none"> ▪ Existing ceiling AFF
General information	<ul style="list-style-type: none"> ○ Every room must have a room tag
Example	

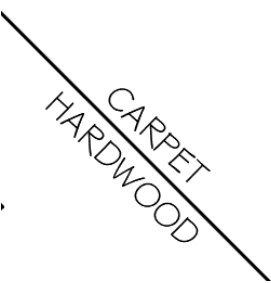SHEETA1.0-SHEET ELEMENTS: FLOORING CHANGES	
Layer	<ul style="list-style-type: none"> ○ A-Floor-Transition <ul style="list-style-type: none"> ▪ Location of flooring changes and text
General information	<ul style="list-style-type: none"> ○ Show every flooring type transition ○ Do not use if a room has a different flooring ○ Apply text to each side of the transition to show material change
Example	

SHEETA1.0-SHEET ELEMENTS: MECHANICAL OBJECTS	
General Layer	<ul style="list-style-type: none"> ○ M-Mech-Exist <ul style="list-style-type: none"> ▪ Existing HVAC objects ○ M-Mech-Notes <ul style="list-style-type: none"> ▪ Existing HVAC notes
General information	<ul style="list-style-type: none"> ○ Examples of common HVAC objects (non-RCP objects) ○ All HVAC / mechanical objects must have a callout: (E)@X'-X" AFF ○ If wall mounted vent / diffuser call out L x W and AFF
Floor mounted diffuser Example	<ul style="list-style-type: none"> ○ M-Mech-Exising <ul style="list-style-type: none"> ▪ Existing floor mounted diffuser ○ E- M-Mech-Notes <ul style="list-style-type: none"> ▪ Callout

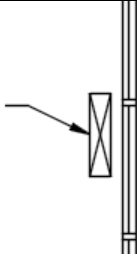	<p>FLOOR MOUNTED HVAC VENT</p> 
<p>Wall mounted diffuser example</p>	<ul style="list-style-type: none"> o M-Mech-Exising <ul style="list-style-type: none"> ▪ Existing wall mounted diffuser o M-Mech-Notes <ul style="list-style-type: none"> ▪ Callout  <p>WALL MOUNTED HVAC VENT 8" X 10" @7'-11" AFF</p>
<p>HVAC controls and miscellaneous</p>	<ul style="list-style-type: none"> o M-Mech-Exising <ul style="list-style-type: none"> ▪ Existing HVAC controls o E- Power-Exist-Notes <ul style="list-style-type: none"> ▪ Callout  <p>RS (E) SM@2'-5"AFF T (E)@2'-5"AFF</p>


SHEETA1.0-SHEET ELEMENTS: ELECTRICAL OBJECTS	
<p>Layer</p>	<ul style="list-style-type: none"> o E-Power-Exist <ul style="list-style-type: none"> ▪ Existing electrical objects o E- Power-Exist-Notes <ul style="list-style-type: none"> ▪ Existing electrical objects notes
<p>General information</p>	<ul style="list-style-type: none"> o Placed by centerline of the object o MEP items will be placed exactly per the provided information from the surveyor. o Outlets, switches, data jacks, blanks, junction boxes, and any other non-life safety objects o All Electrical /data objects must have a callout: (E)@X'-X" AFF o For existing Follett sites, please place the server located in the BOH

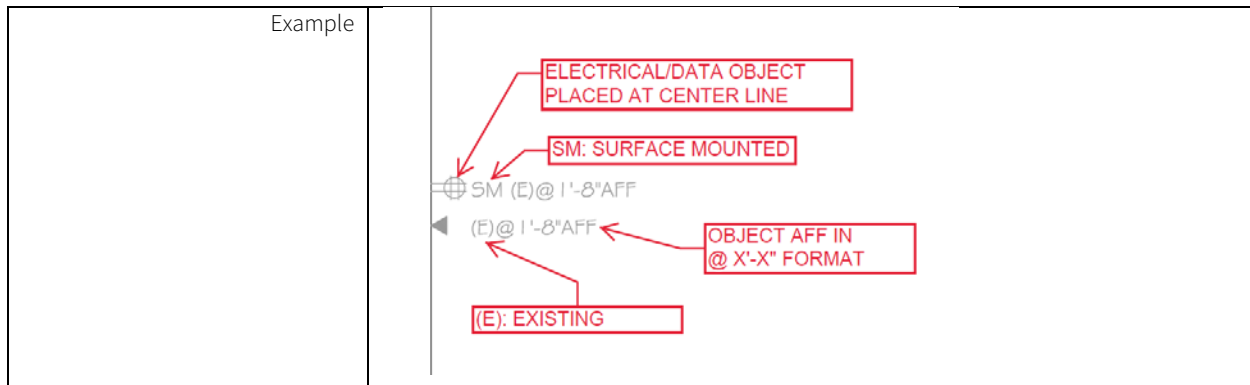


SHEETA1.0-SHEET ELEMENTS: PLUMBING OBJECTS	
Layer	<ul style="list-style-type: none"> o p <ul style="list-style-type: none"> ▪ Existing plumbing objects o P-Eqpm <ul style="list-style-type: none"> ▪ Existing plumbing fixtures o A-Blockout-Note <ul style="list-style-type: none"> ▪ Existing plumbing notes
General information	<ul style="list-style-type: none"> o All plumbing object wall or floor mounted o All wall mounted plumbing objects must have a callout: (E)@X'-X" AFF o Restroom grab bars o Toilets and sinks place by centerline
examples	

SHEETA1.0-SHEET ELEMENTS: LIFE SAFETY	
Layer	<ul style="list-style-type: none"> o Life Safety <ul style="list-style-type: none"> ▪ Existing life safety (fire strobes, fire pull, extinguishers, etc.) o E-Power-Exist-Notes <ul style="list-style-type: none"> ▪ Existing life safety notes


SHEETA1.0-SHEET ELEMENTS: GENERAL CALLOUTS AND NOTES	
Layer	<ul style="list-style-type: none"> o A-Elev-Symbol <ul style="list-style-type: none"> ▪ Elevations symbols o A-Blockout-Note <ul style="list-style-type: none"> ▪ Existing item notes
General information	<ul style="list-style-type: none"> o General notes for the blockout plan o Confirm elevation callouts match elevations o The first elevations must be the exterior elevations, then moving inside the sales floor counter clockwise around the space o No callouts or notes should overlap on the same sheet
examples	<ul style="list-style-type: none"> o Incorrect callout and note placement <div data-bbox="565 611 1149 1066" data-label="Diagram"> </div> o Correct callout and note placement <div data-bbox="565 1094 1149 1470" data-label="Diagram"> </div> o Example of elevation call out locations <div data-bbox="565 1480 1149 1516" data-label="Diagram"> </div>

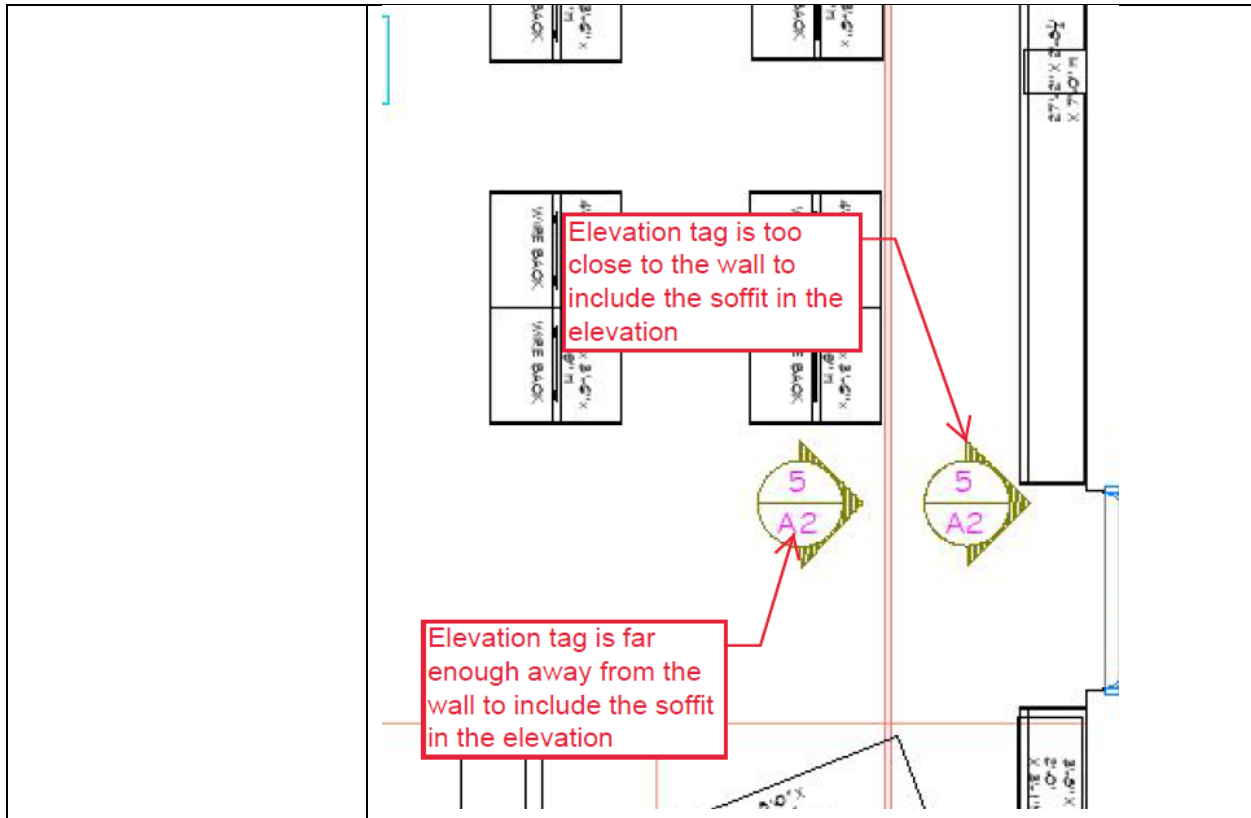

SHEETA1.0-SHEET ELEMENTS: FIXTURES, FUNITURE, AND GONDOLAS					
Layer	<ul style="list-style-type: none"> o A-Fixt-Existing <ul style="list-style-type: none"> ▪ All existing fixtures, furniture, gondolas, built in case work (including checkouts) pegboard/slat wall o A-Fixt-Existing <ul style="list-style-type: none"> ▪ All existing fixtures, furniture, gondolas, and built ins text 				
General information	<ul style="list-style-type: none"> o All wall mounted fixtures, gondolas, and furniture around the perimeter of book sales area, with size (W x D x H) and back panel type. (smooth, slat wall, peg board) o Gondolas must show panel sections and endcaps o All non-movable fixtures, gondolas, and furniture though the book sales area, with size (W x D x H) 				
examples	<ul style="list-style-type: none"> o Wall mounted fixtures/gondolas <table border="1" style="margin-left: 40px;"> <tr> <td style="text-align: center;">4'-0" X 1'-8" X 7'-2"H SLAT WALL</td> <td style="text-align: center;">4'-0" X 1'-8" X 7'-2"H SLAT WALL</td> </tr> </table> o Wall mounted panels <table border="1" style="margin-left: 40px;"> <tr> <td style="text-align: center;">4'-0" X 1" X 7'-0"H SLAT WALL</td> <td style="text-align: center;">4'-0" X 1" X 7'-0"H PEG BOARD</td> </tr> </table> o Non-moveable fixture/gondola 	4'-0" X 1'-8" X 7'-2"H SLAT WALL	4'-0" X 1'-8" X 7'-2"H SLAT WALL	4'-0" X 1" X 7'-0"H SLAT WALL	4'-0" X 1" X 7'-0"H PEG BOARD
4'-0" X 1'-8" X 7'-2"H SLAT WALL	4'-0" X 1'-8" X 7'-2"H SLAT WALL				
4'-0" X 1" X 7'-0"H SLAT WALL	4'-0" X 1" X 7'-0"H PEG BOARD				

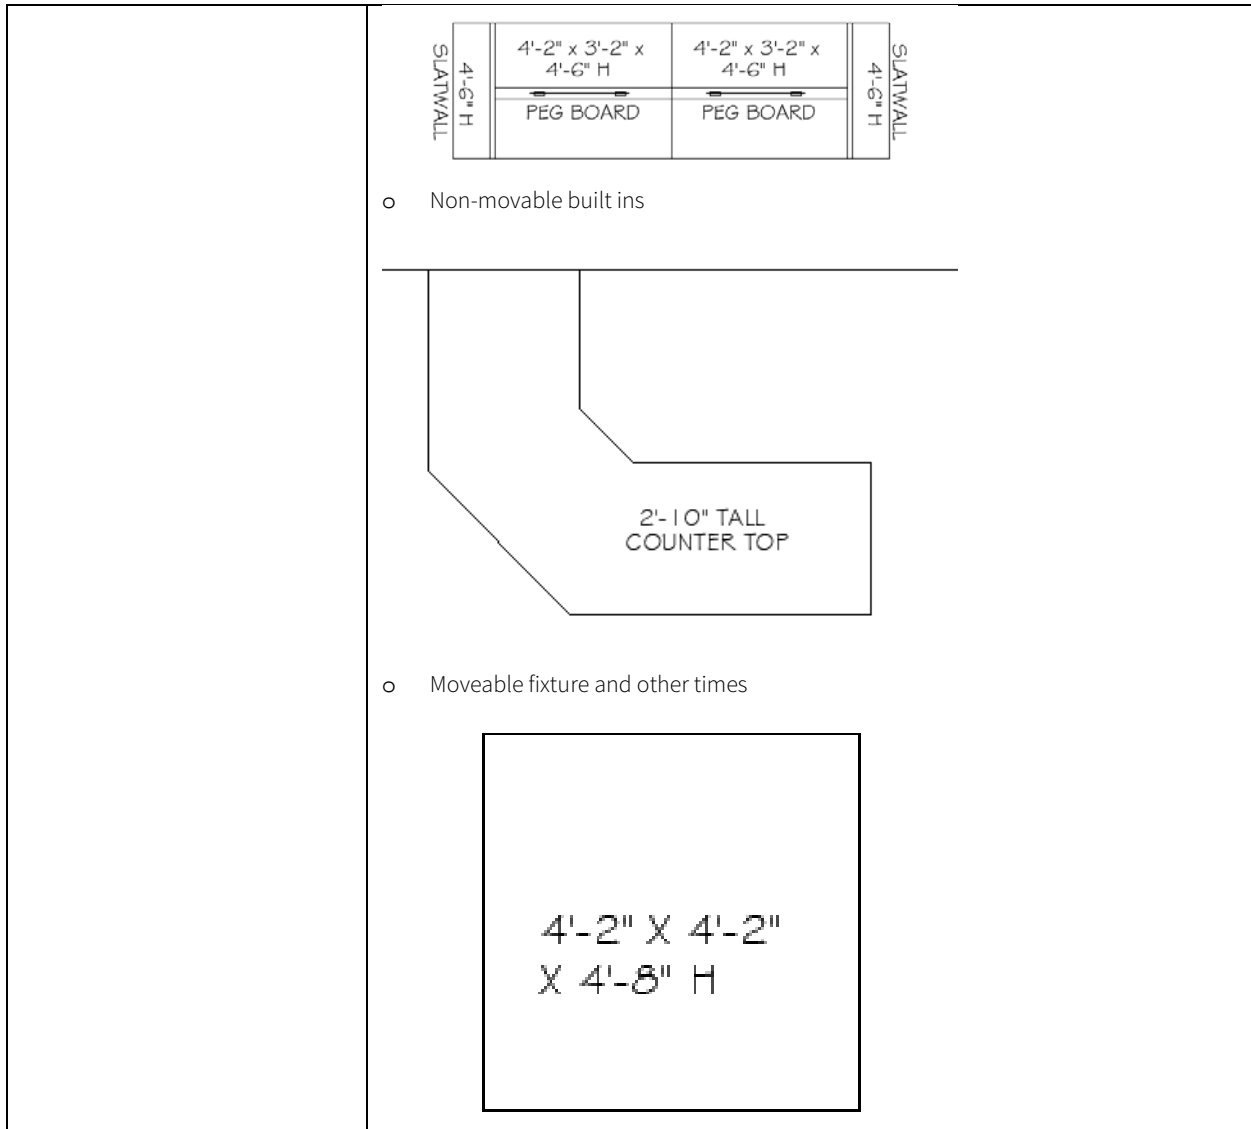


SHEET A1.0-SHEET ELEMENTS: VERTICAL FLOOR ITEMS	
Layer	<ul style="list-style-type: none"> ○ A-Floor-Ver <ul style="list-style-type: none"> ▪ Vertical floor changes, stairs, and stair break lines ○ A-Blockout-Note <ul style="list-style-type: none"> ▪ Vertical floor change notes
General information	<ul style="list-style-type: none"> ○ Show the exact location of all vertical floor changes, stairs, and use stair break lines.

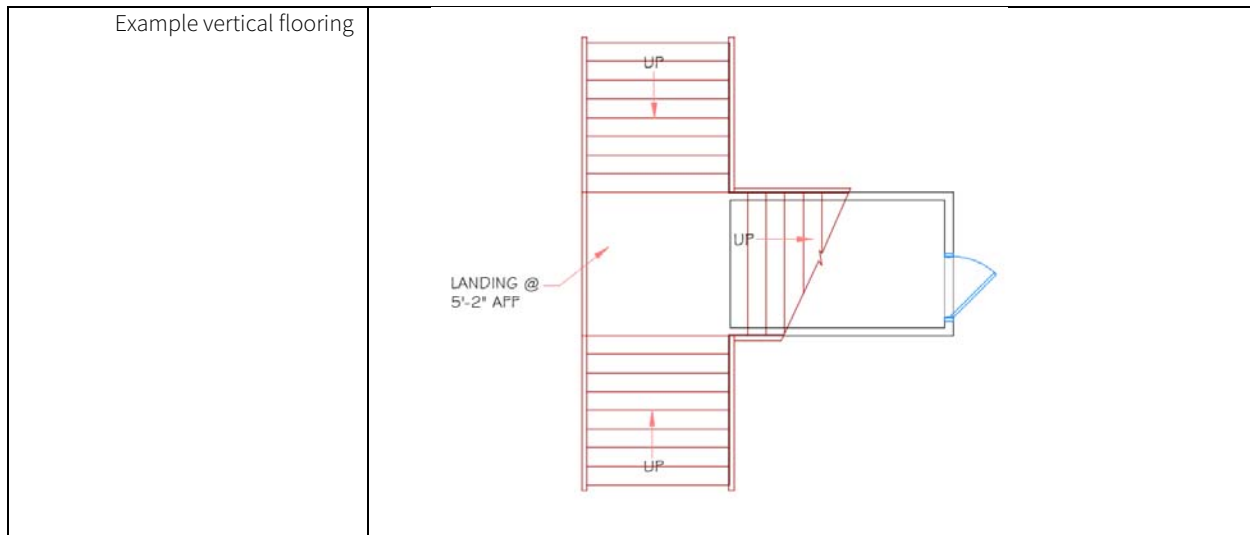

SHEETA1.0-SHEET ELEMENTS: ELEVATORS	
<p>Layer</p>	<ul style="list-style-type: none"> o A-Wall-Exist <ul style="list-style-type: none"> ▪ Existing walls around elevator o A-Blockout-Note <ul style="list-style-type: none"> ▪ Elevator notes o A-Door <ul style="list-style-type: none"> ▪ Elevator doors o A-Door-Header <ul style="list-style-type: none"> ▪ Elevator door header
<p>General information</p>	<ul style="list-style-type: none"> o Show elevators with "X"
<p>Example</p>	

SHEETA1.0-SHEET ELEMENTS: NO ACCESS/NON-FOLLETT AREAS	
<p>Layer</p>	<ul style="list-style-type: none"> o A-Anno-Rmnm <ul style="list-style-type: none"> ▪ Room names
<p>General information</p>	<ul style="list-style-type: none"> o Use a callout to identify areas of no or limited access o Use a callout to identify areas that are not Follett's

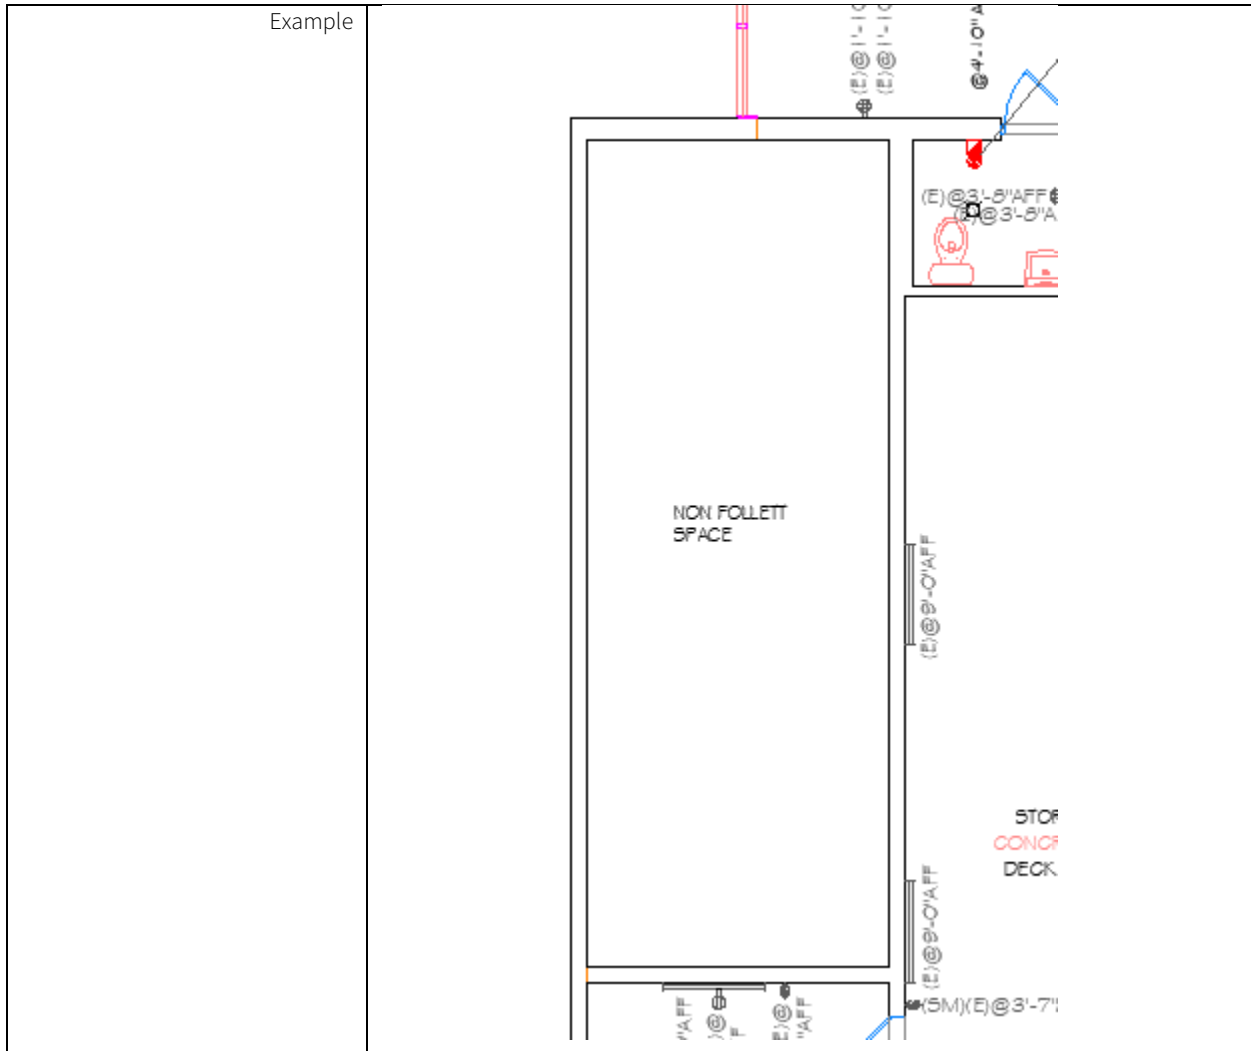

SHEET A1.1 REFLECTED CEILING PLAN

GENERAL NOTES

DRAWING AREA

SHEET NAME

SHEET NUMBER

DETAIL TAG

REFLECTED CEILING PLAN
SCALE: 1/8" = 1'-0"
PLAN 100211

GENERAL CONDITIONS NOTES
GENERAL NOTES
**DO WE HAVE ANY GENERAL CONSTRUCTION NOTES
PROJECT SPECIFIC NOTES

DATE
A1.2

Title Block	<ul style="list-style-type: none"> o Fill in all title block information o Update the total SF in the title block o Sheet number: A1.1 o Sheet name: Reflected Ceiling Plan
Detail Tag	<ul style="list-style-type: none"> o Listed scale will match the viewport scale o Adjust north arrow to correct position
Drawing area	<ul style="list-style-type: none"> o Viewport: 1/4"=1'-0" if possible, 1/8" = 1'-0" is the smallest. If the drawing will not fit on 1/8" = 1'-0" then a key plan and blowup areas are required at 1/4"=1'-0"

SHEET A1.1-SHEET ELEMENTS: CEILING GRIDS & SOFFITS

Layer	<ul style="list-style-type: none"> o A-Clng-Grid <ul style="list-style-type: none"> ▪ Existing ceiling grid o A-Clng-Ovhd <ul style="list-style-type: none"> ▪ Existing overhead elements (bulkheads, beams, etc.) o A-Clng-Soffit <ul style="list-style-type: none"> ▪ Existing ceiling soffits o A-Clng-Symb <ul style="list-style-type: none"> ▪ All existing ceiling mounted items o A-Clng-Text <ul style="list-style-type: none"> ▪ Existing ceiling notes
General information	<ul style="list-style-type: none"> o All ceiling grids must be cut at walls and soffits o No overlapping lines

SHEETA1.1-SHEET ELEMENTS: CEILING HVAC OBJECTS	
Layer	<ul style="list-style-type: none"> o M-Mech-Existing <ul style="list-style-type: none"> ▪ Existing ceiling HVAC
General information	<ul style="list-style-type: none"> o All HVAC objects must be snapped to the grid (if applicable) o Use only blocks and symbols provided in the CAD template o No overlapping lines

SHEETA1.1-SHEET ELEMENTS: LIGHTING AND OTHER OBJECTS	
Layer	<ul style="list-style-type: none"> o Life safety <ul style="list-style-type: none"> ▪ Life safety items o A-Cng-Symb <ul style="list-style-type: none"> ▪ Ceiling mounted objects o T-Wifi <ul style="list-style-type: none"> ▪ Wifi routers and extenders o E-Lite-Exist <ul style="list-style-type: none"> ▪ All existing lights
General information	<ul style="list-style-type: none"> o Use only blocks and symbols provided in the CAD template o No overlapping lines

SHEET A1A.0 PHOTO SURVEY

DRAWING AREA

SHEET NAME

SHEET NUMBER

#1493 Valdosta GA ← **SCHOOL NAME**


1 PHOTO SURVEY PLAN ← **DETAIL TAG**
SCALE: 1/8" = 1'-0"

DATE: DATE
A1A.0

Title Block	<ul style="list-style-type: none"> ○ Fill in all title block information ○ Update the total SF in the title block ○ Sheet number: A1A.0 ○ Sheet name: Photo Survey
Detail Tag	<ul style="list-style-type: none"> ○ Listed scale will match the viewport scale ○ Adjust north arrow to correct position
School name	<ul style="list-style-type: none"> ○ Enter current project school name
Drawing area	<ul style="list-style-type: none"> ○ Viewport: 1/4"=1'-0" if possible, 1/8" = 1'-0" is the smallest. If the drawing will not fit on 1/8" = 1'-0" then a key plan and blowup areas are required at 1/4"=1'-0"

SHEETA1A.0-SHEET ELEMENTS: PHOTO BUBBLES


Layer	<ul style="list-style-type: none"> ○ A-Photo-Tag <ul style="list-style-type: none"> ▪ All site survey photo bubbles
General information	<ul style="list-style-type: none"> ○ Photo bubbles represent photo locations in groups ○ Photo locations will be provided by the surveyor in a photo key ○ No bubbles should overlap ○ No bubble should show more than 180° ○ Photo Survey sheet must show existing fixtures, furniture, and gondolas
Examples	<ul style="list-style-type: none"> ○ Correct photo bubble

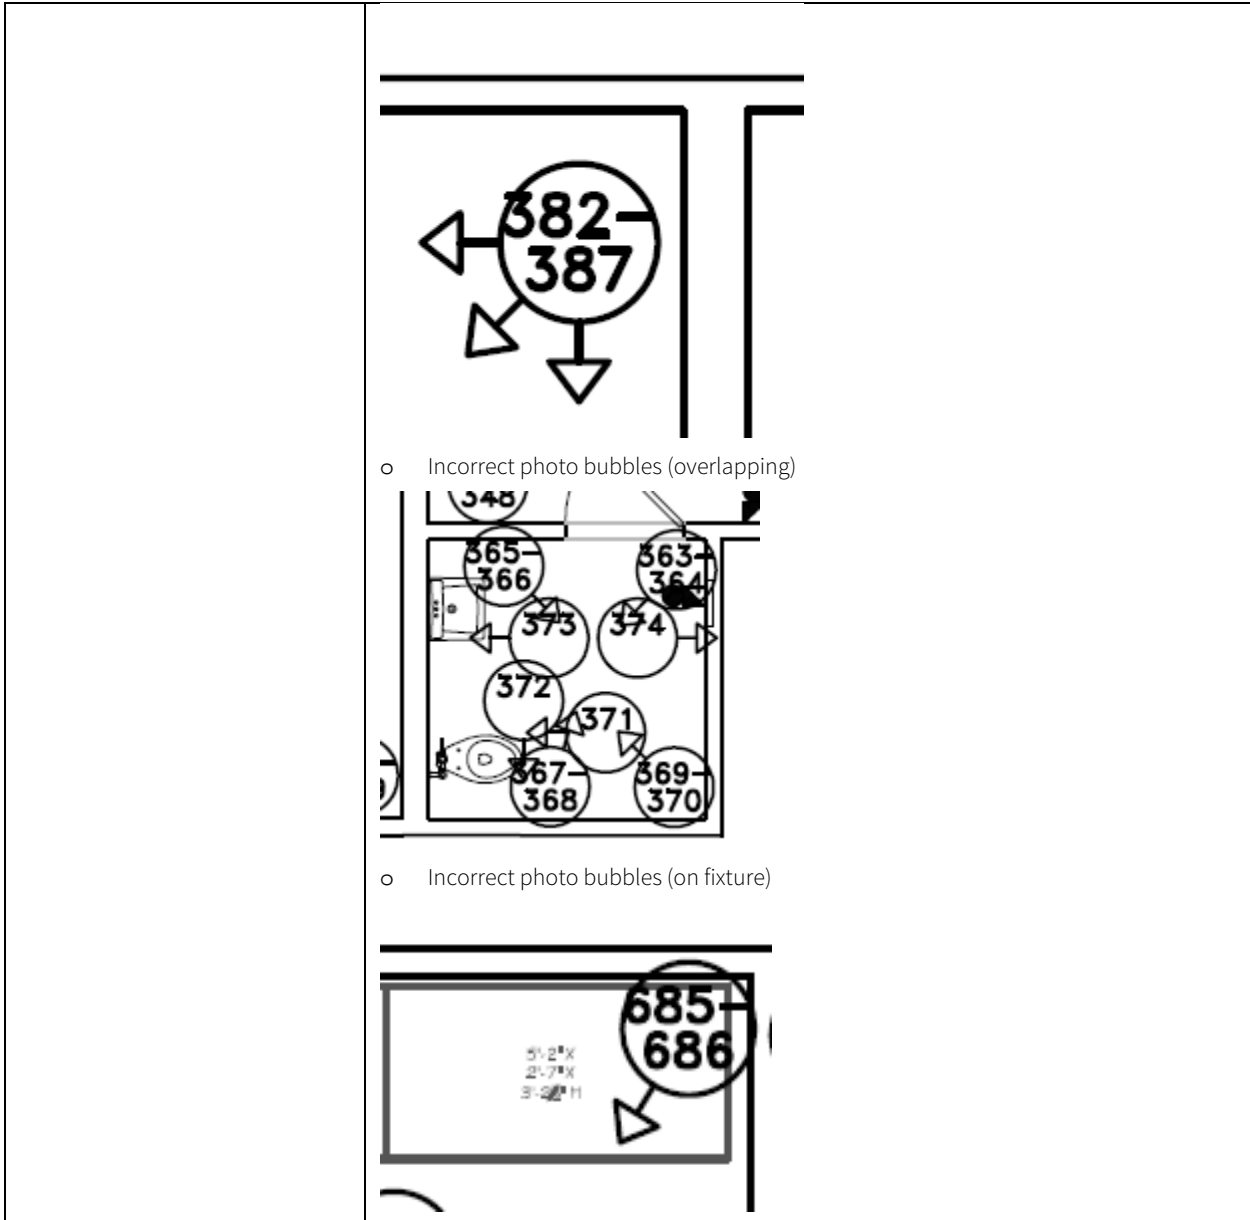

o Incorrect photo bubbles (overlapping)

o Incorrect photo bubbles (on fixture)


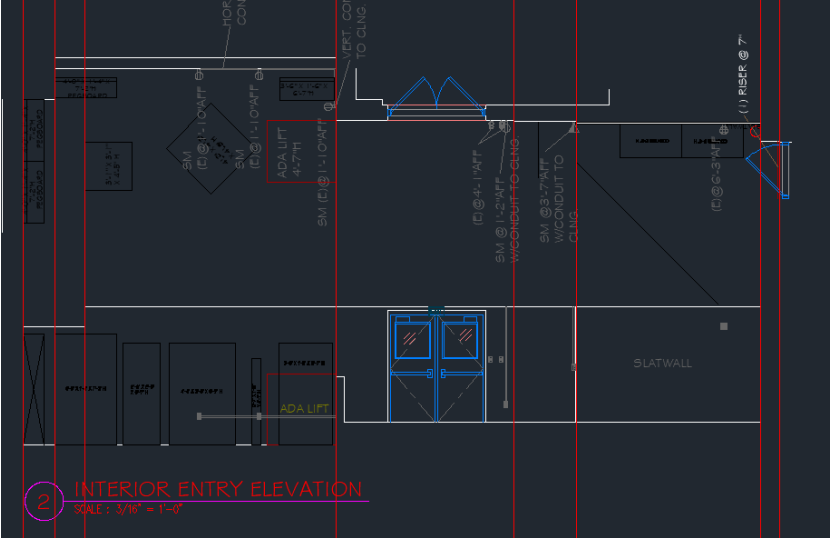
SHEET A2.0 PHOTO ELEVATIONS

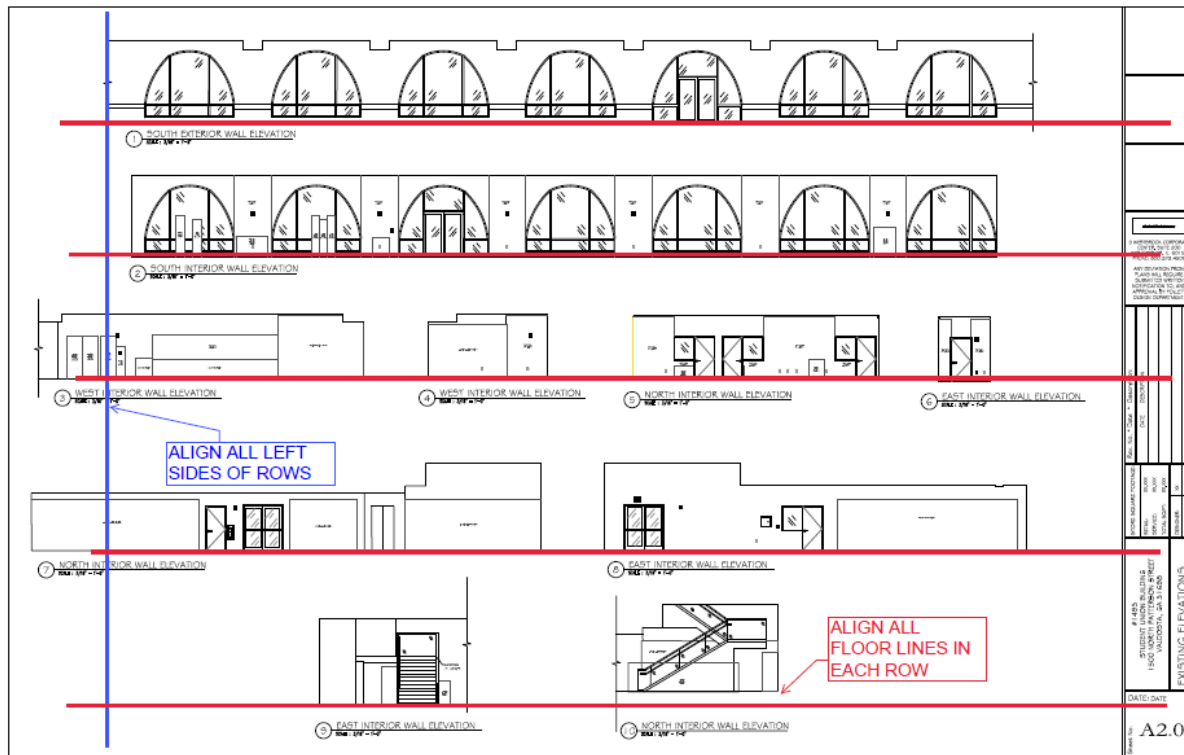
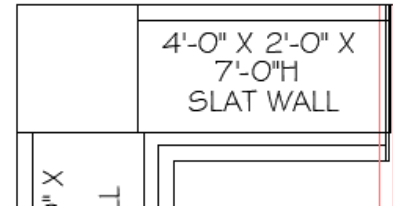



Title Block	<ul style="list-style-type: none"> o Fill in all title block information o Sheet number: A2.0 (A2.1 as needed) o Sheet name: Existing elevations
Detail Tag	<ul style="list-style-type: none"> o Each elevation should have its own detail callout o Each detail call out should have the wall direction on it
Drawing area QC	<ul style="list-style-type: none"> o Once QC of the elevations is complete, set up the sheet. o Use the MODEL space box to set up the sheet o Align the all left side walls and elevations callouts vertically and horizontally


SHEET A2.0-SHEET ELEMENTS: EXISTING ELEVATIONS


General information	<ul style="list-style-type: none"> o Use the same layers for items on the elevations and in the plans o All elevations must be drawn in the elevation area o Wall mounted fixtures and gondolas must show each section, not the overall length attached to the wall o Sections though wall mounted fixtures and gondolas will be shown as a box with an "X" o Areas that are open to beyond must show an "x" in the opening and text "Open to Beyond" o Soffits will be shown in elevation and section of the elevations o MEP items will be place to the centerline of the object both on plan and elevations unless noted otherwise o Door elevations will be on the correct layer, show the door swing with a dashed line, and show any glass and hardware on the door
---------------------	---


Elevations area	<ul style="list-style-type: none"> o Layout elevations within the elevation area o X-clip or copy plan above each elevation o Add construction lines to show plan/elevations line up in elevation area
examples	<ul style="list-style-type: none"> o Elevation area <div data-bbox="565 373 1390 743"> <p>CAD DRAFTER: SHOW A TRIMMED PLAN FOR EACH ELEVATION FOR QC STAFF</p>  </div> o Individual elevations <div data-bbox="565 793 1390 1327">  <p>2 INTERIOR ENTRY ELEVATION SCALE: 3/16" = 1'-0"</p> </div>

SHEETA2.0-SHEET ELEMENTS: WALL MOUNDED GONDOLAS	
Examples	<ul style="list-style-type: none"> o Wall mounted gondolas plan <div data-bbox="600 1491 1136 1596">  </div> o Wall mounted gondolas elevation <div data-bbox="600 1596 990 1806">  </div>

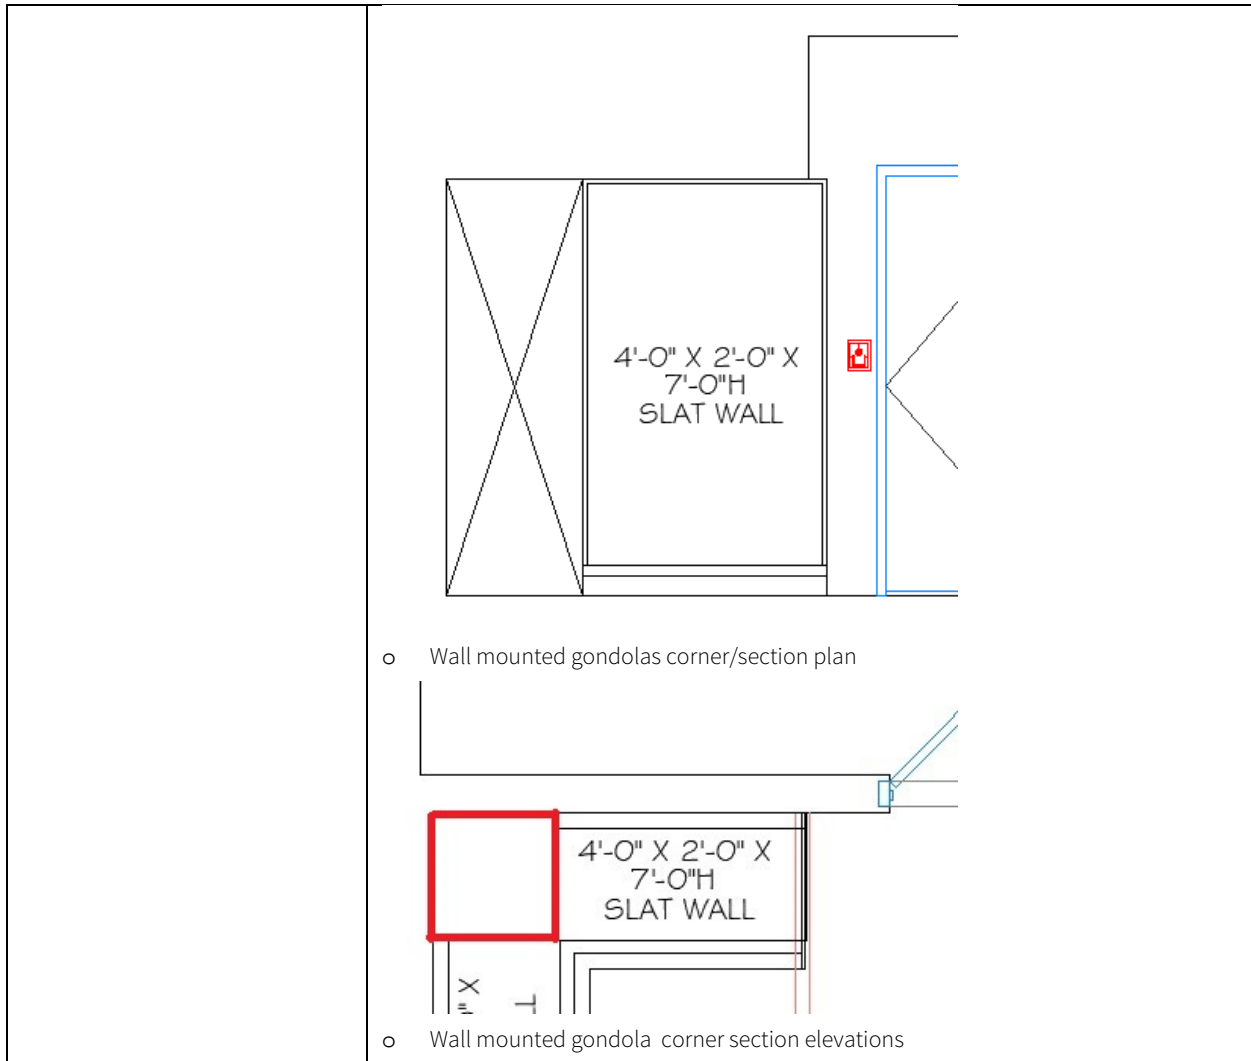

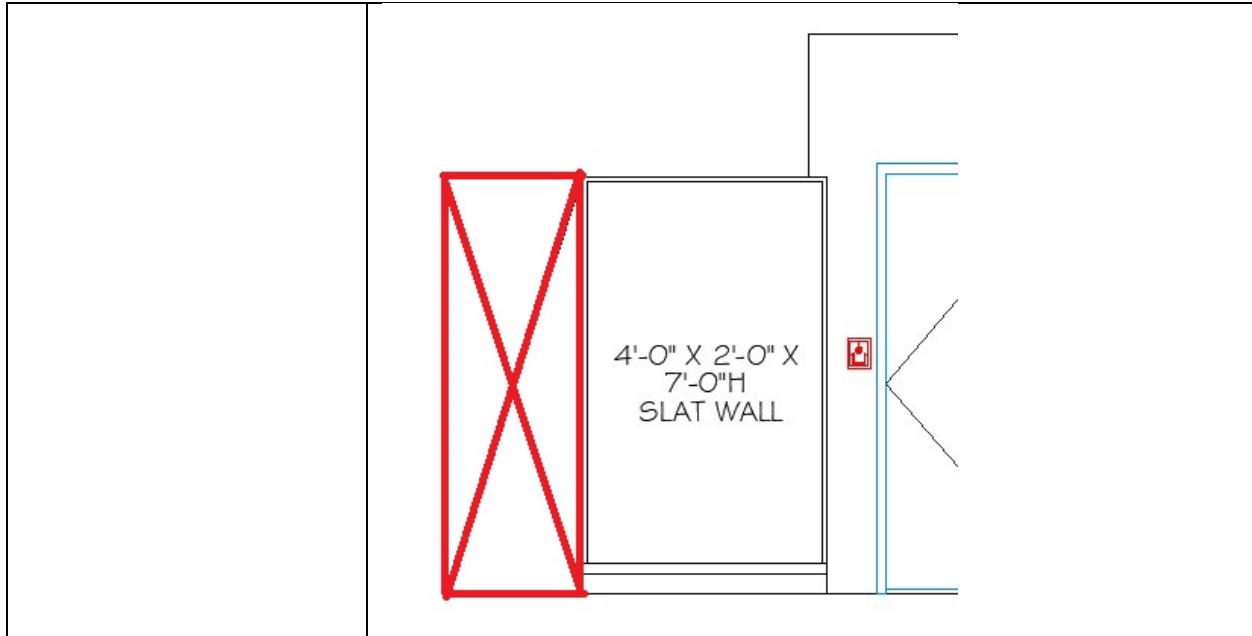

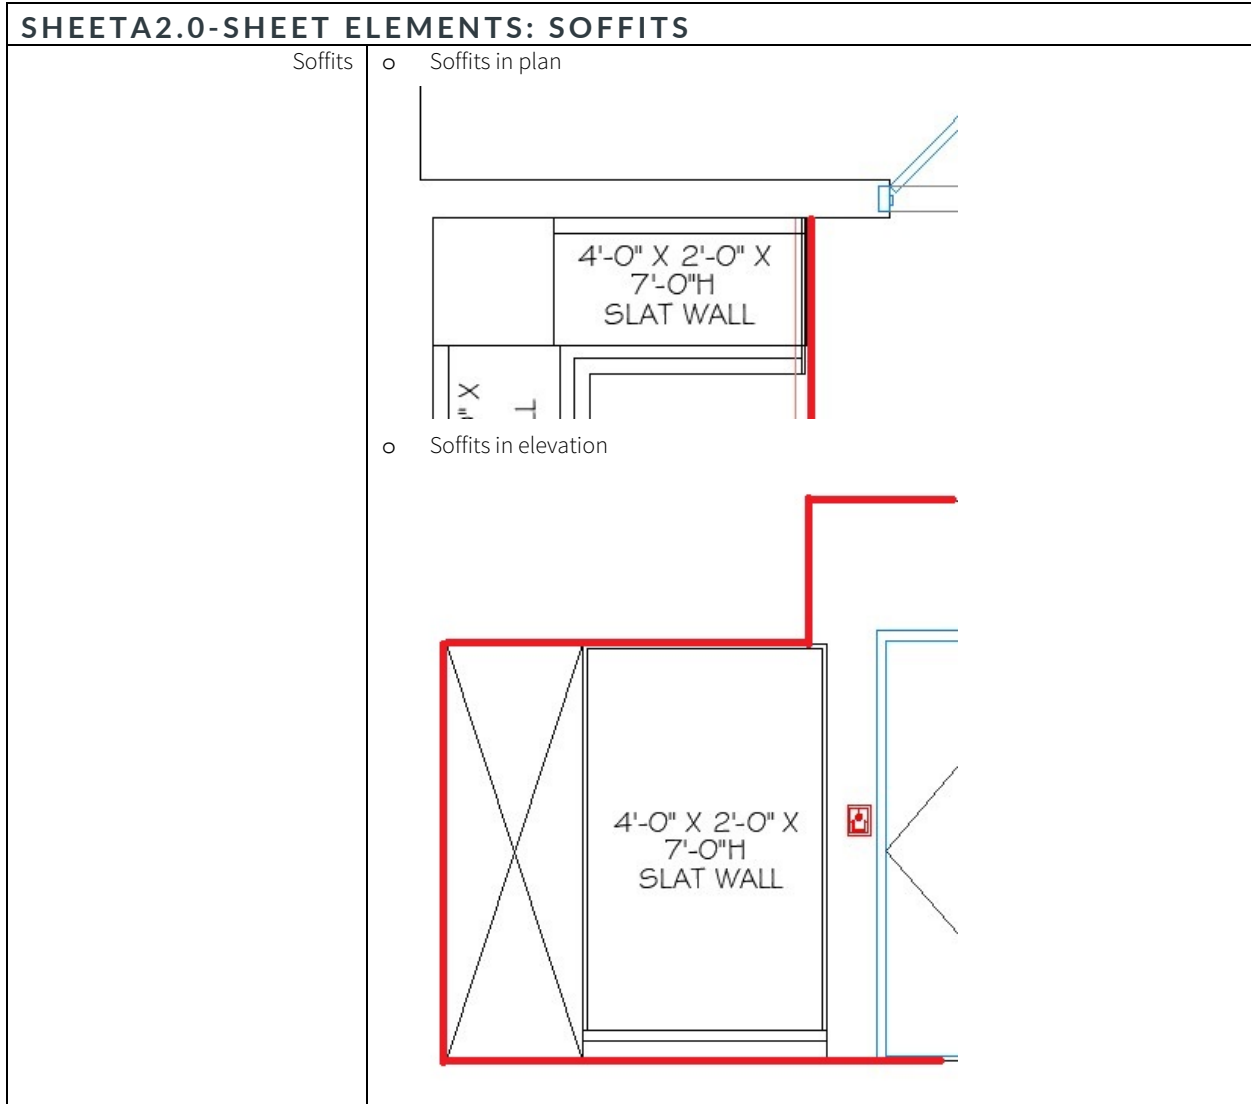

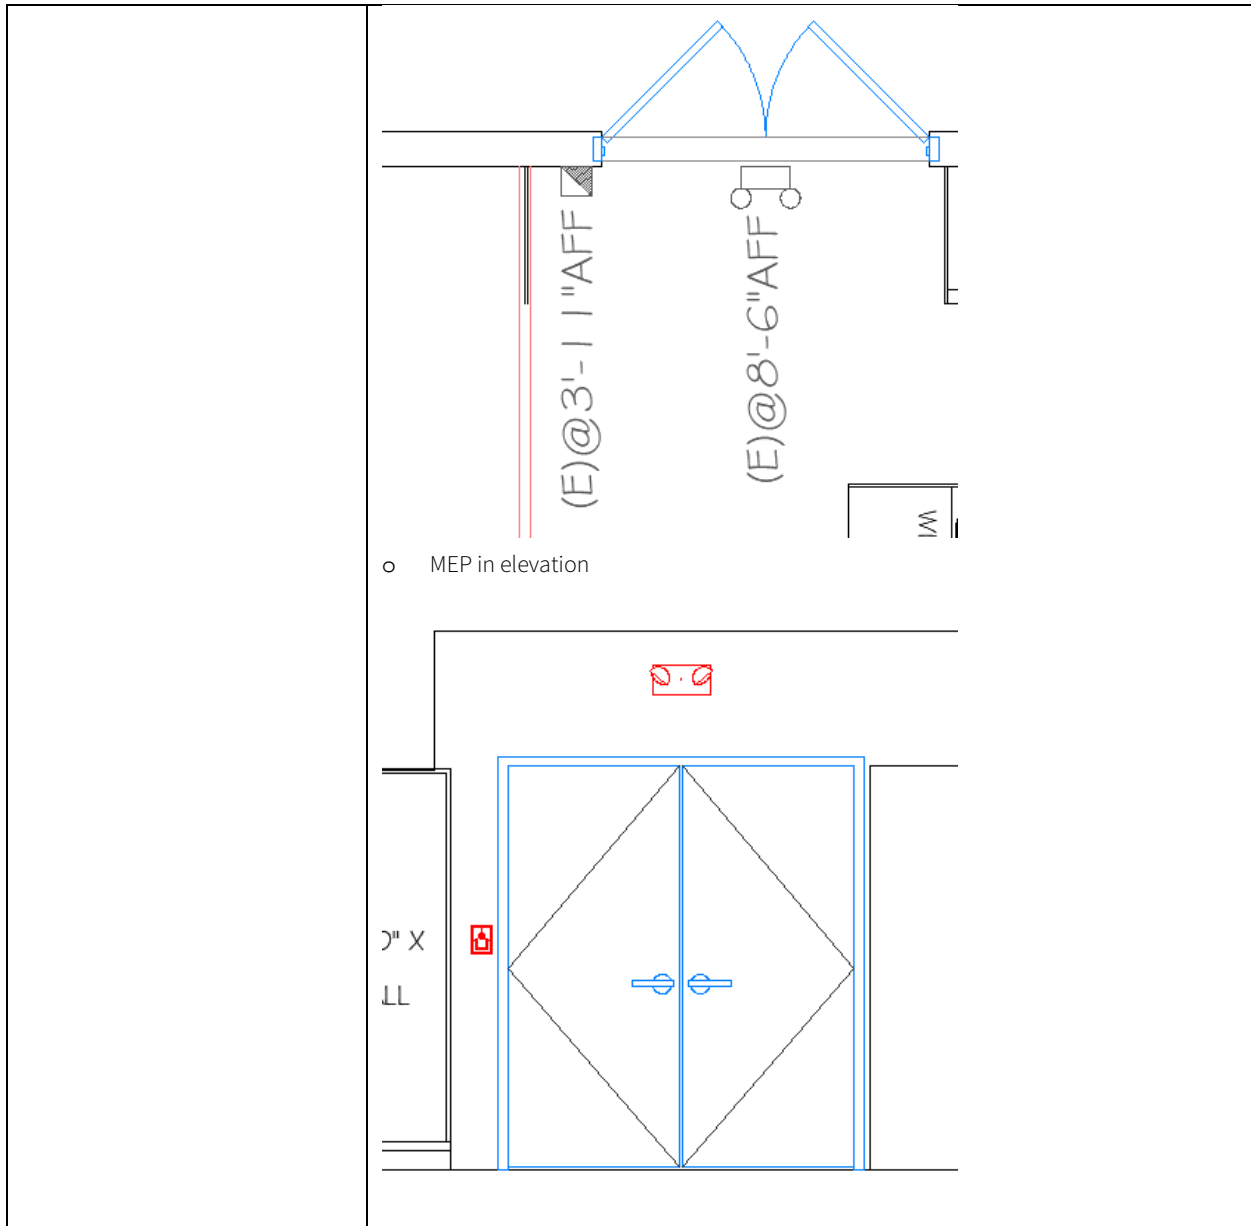

SHEETA2.0-SHEET ELEMENTS: EXISTING ELEVATIONS SEQUENCE

Layer	<ul style="list-style-type: none"> o A-Elev-Symbol <ul style="list-style-type: none"> ▪ Elevations symbols
General information	<ul style="list-style-type: none"> o The first elevations will always be the exterior entrance side of the building o After the exterior, move inside and move around the sales floor in a counter clockwise rotation. o Confirm all callouts on the A1.0 sheet match the elevation callouts

